


REAR VIEW

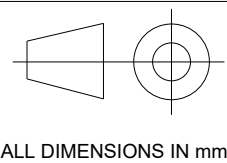

Size

Scale

1:50

Date drawn

Created by

Approved by

Title

Tiger Modular

DWG No.

MAXI-GA-001

 
Rev.

Sheet

ISO VIEW OF RIGHT TO LEFT OPENING BIFOLD



ISO VIEW OF LEFT TO RIGHT OPENING BIFOLD



ALL DIMENSIONS IN mm.

Size

Scale

1:50

Date drawn

Created by

Approved by

Title

Tiger Modular

DWG No.

MAXI-GA-001


Rev.

Sheet

ISO VIEW OF DOUBLE DOOR - FIXED PANE ON LEFT



ISO VIEW OF DOUBLE DOOR - FIXED PANE ON RIGHT

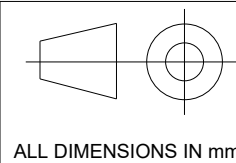

ALL DIMENSIONS IN mm.

Size

Scale

Created by

Title

Tiger Modular

Date drawn

Approved by



DWG No.

MAXI-GA-001

Rev.

Sheet

ELECTRICAL LAYOUT / PLAN VIEW
 DOUBLE DOORS FIXED PANE ON LEFT

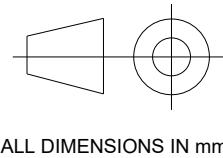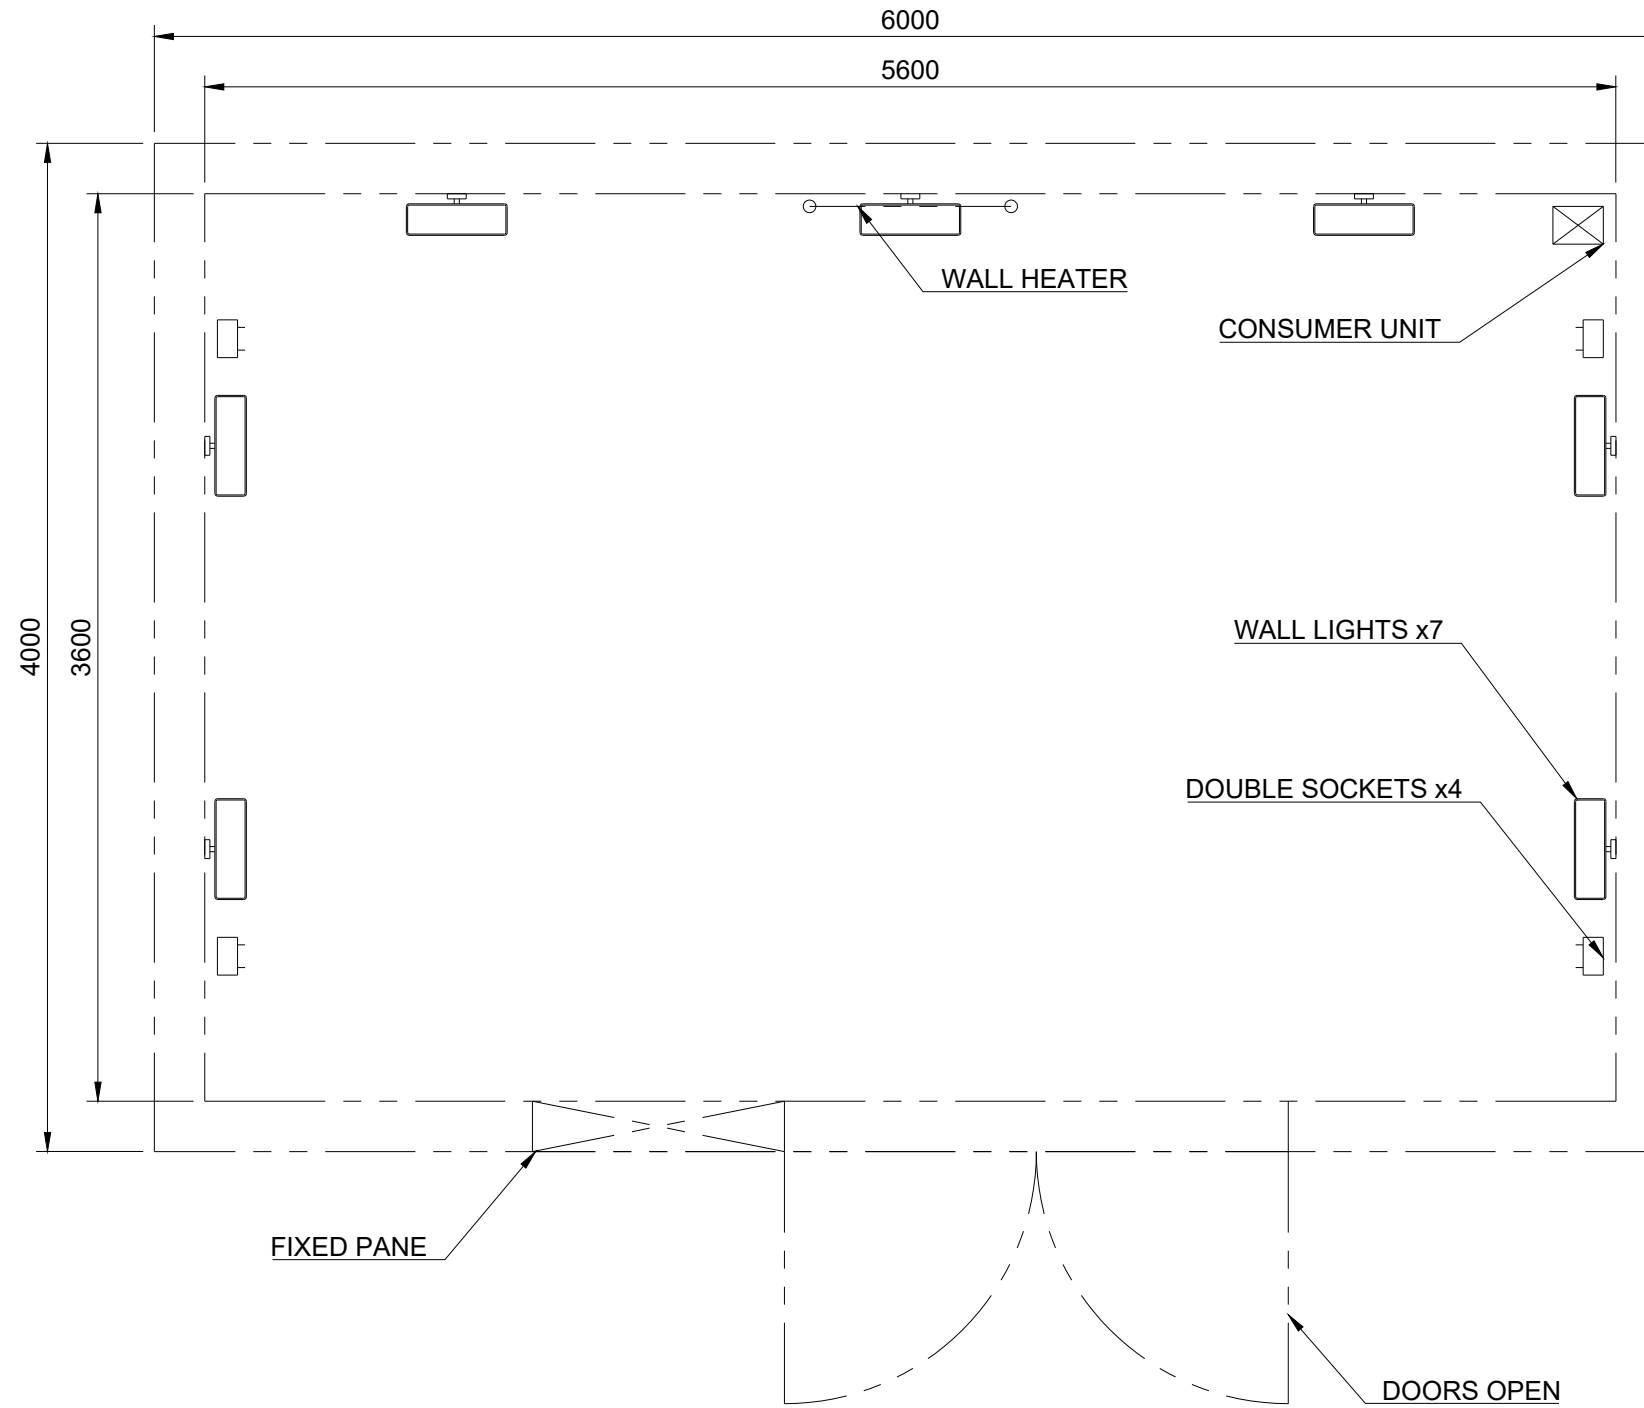

Size

Scale

1:30

Date drawn

Created by

Approved by

Title

Tiger Modular



DWG No.

MAXI-GA-001

Rev.

Sheet

ELECTRICAL LAYOUT / PLAN VIEW
 DOUBLE DOORS FIXED PANE ON RIGHT

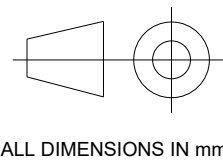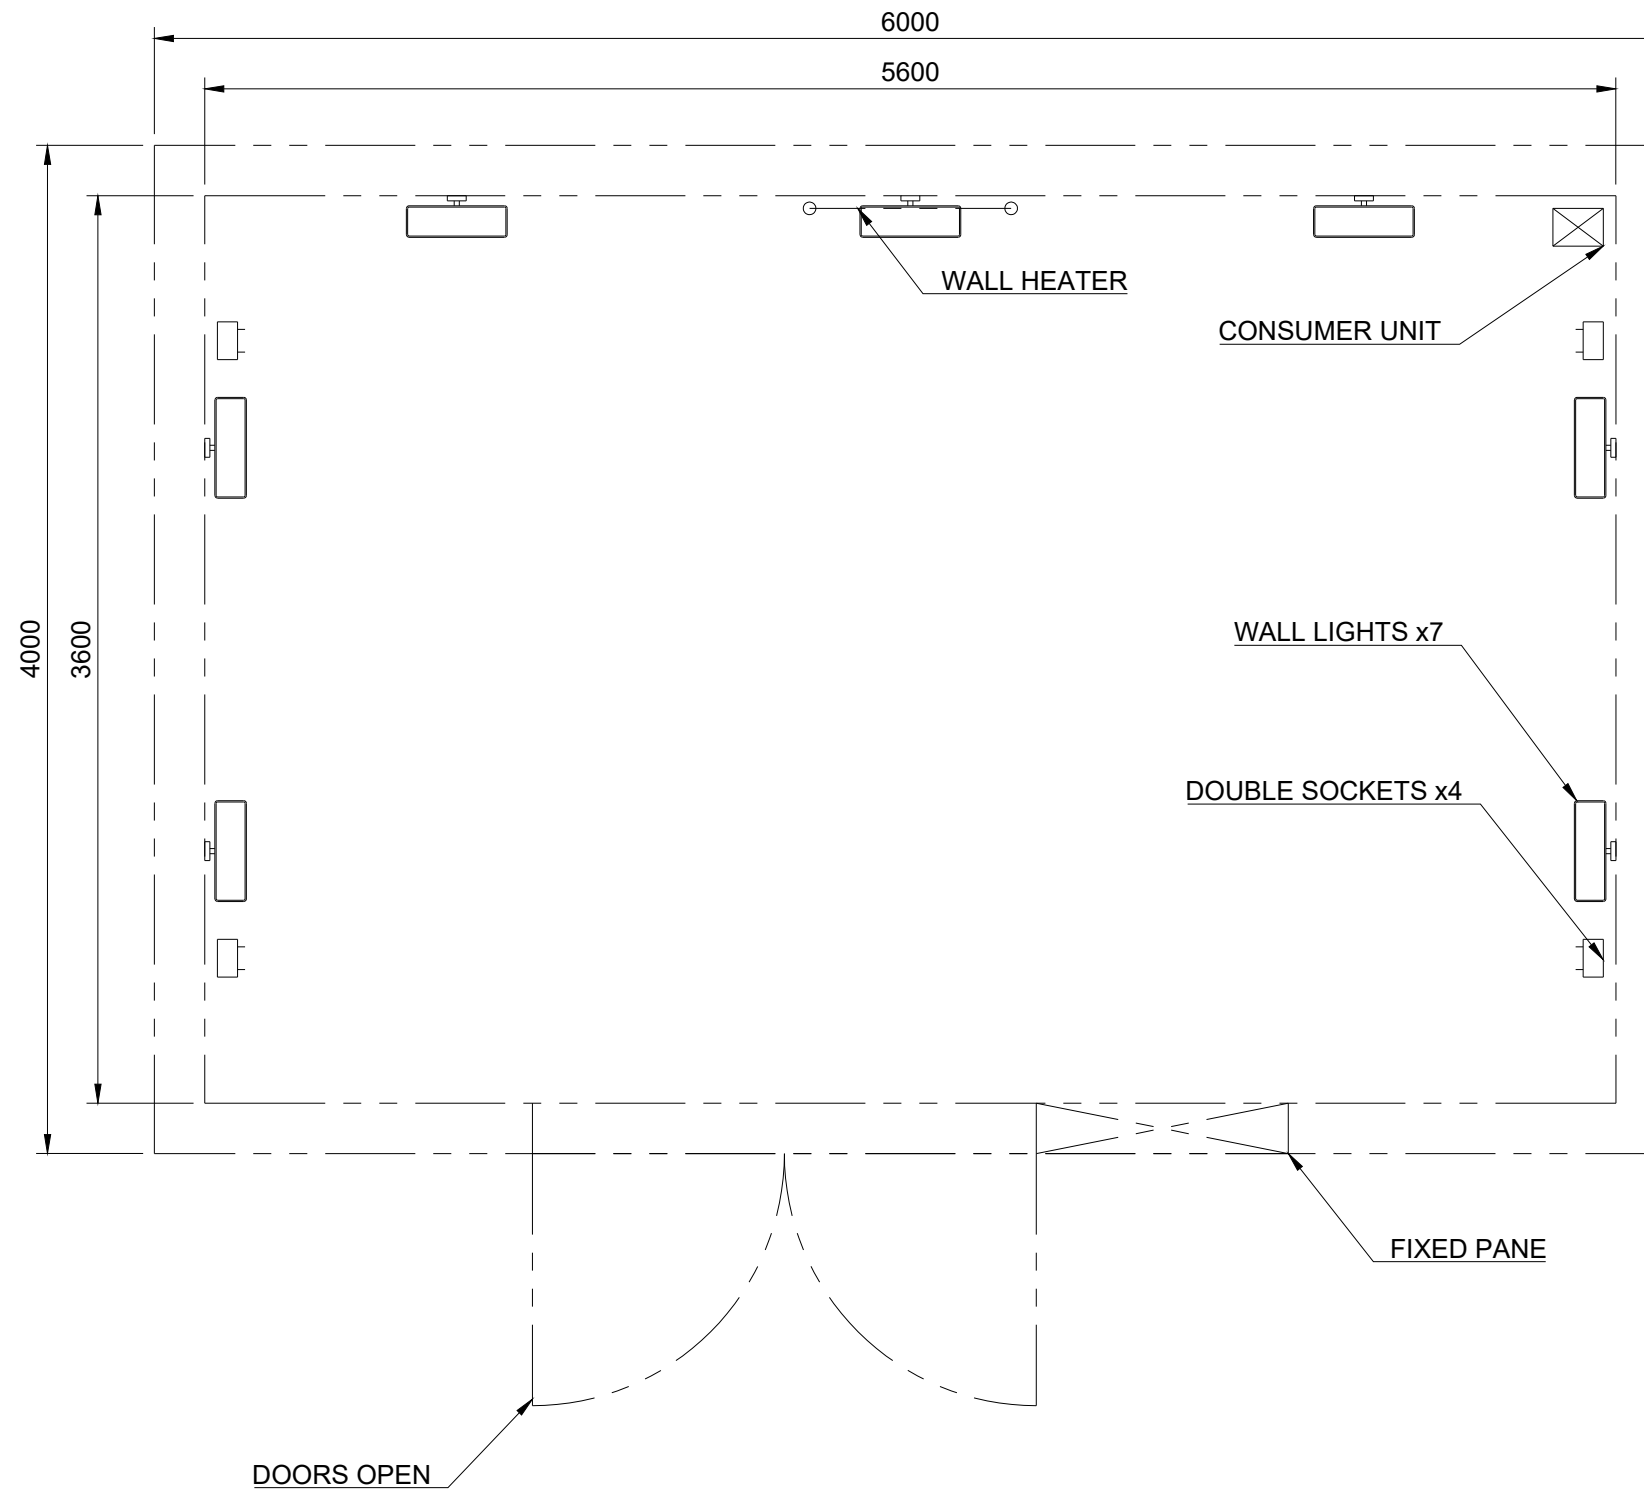

Size

Scale

1:30

Date drawn

Created by

Approved by

Title

Tiger Modular



DWG No.

MAXI-GA-001

Rev.



Sheet

ELECTRICAL LAYOUT / PLAN VIEW
 BIFOLD RIGHT TO LEFT OPENING

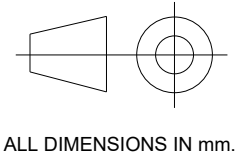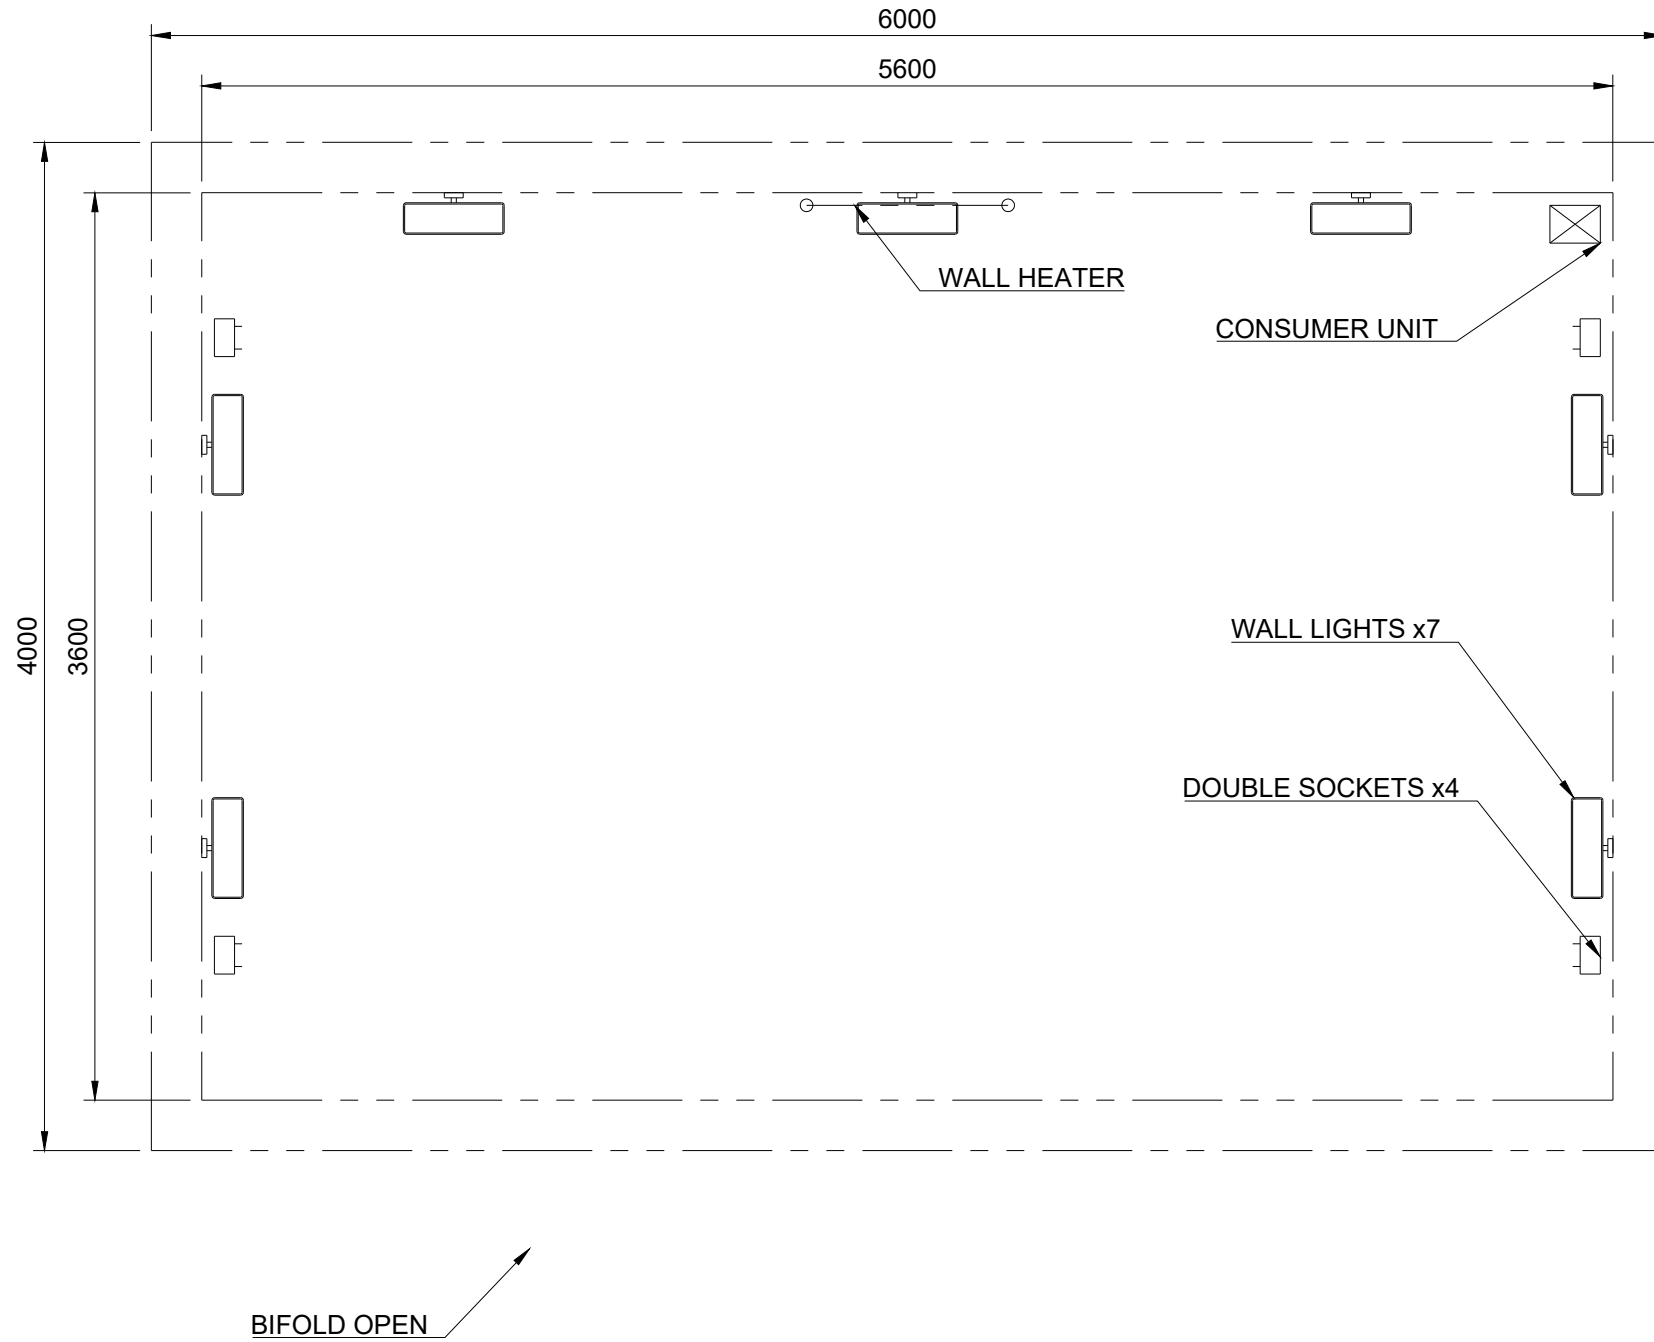

Size	Scale	Created by	Title	Rev.	Sheet
	1:30		Tiger Modular		
	Date drawn	Approved by	DWG No.		
			MAXI-GA-001		

ELECTRICAL LAYOUT / PLAN VIEW
 BIFOLD LEFT TO RIGHT OPENING

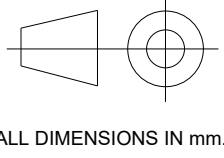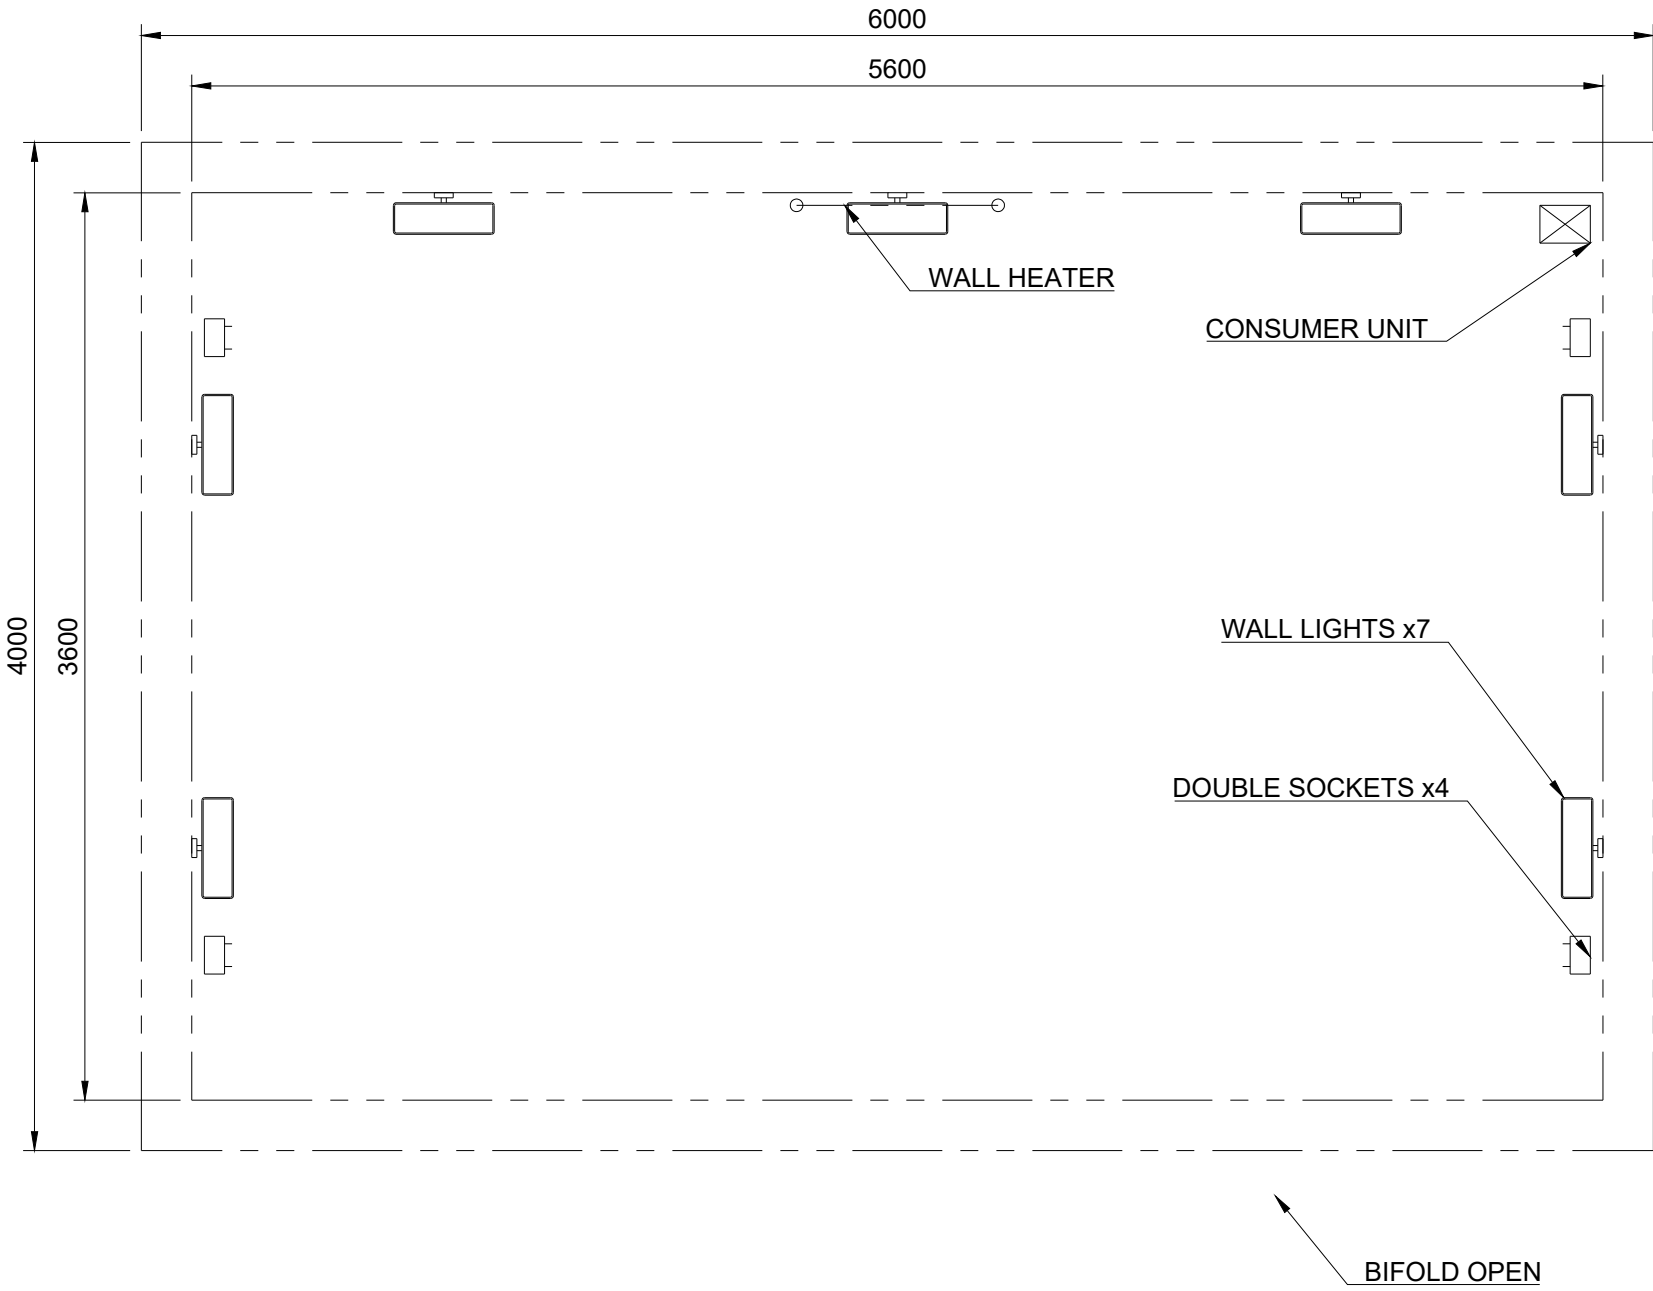

Size	Scale	Created by	Title	
	1:30		Tiger Modular	
Date drawn	Approved by	DWG No.		Rev.
		MAXI-GA-001		Sheet