 


REAR VIEW



ALL DIMENSIONS IN mm.

Size

Scale

1:40

Date drawn

Created by

Approved by

Title

Tiger Modular

DWG No.

MIDI-GA-001


Rev.

Sheet

ISO VIEW OF RIGHT TO LEFT OPENING BIFOLD



ISO VIEW OF LEFT TO RIGHT OPENING BIFOLD

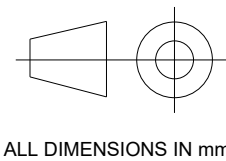


Size	Scale	Created by	Title	Rev.	Sheet
	1:40		Tiger Modular		
Date drawn	Approved by	DWG No.			
		MIDI-GA-001			

ISO VIEW OF DOUBLE DOOR - FIXED PANE ON LEFT



 ISO VIEW OF DOUBLE DOOR - FIXED PANE ON RIGHT



ALL DIMENSIONS IN mm.

Size

Scale

Created by

Title

Tiger Modular

Date drawn

Approved by


DWG No.

MIDI-GA-001



Rev.

Sheet

ELECTRICAL LAYOUT / PLAN VIEW
DOUBLE DOORS FIXED PANE ON LEFT

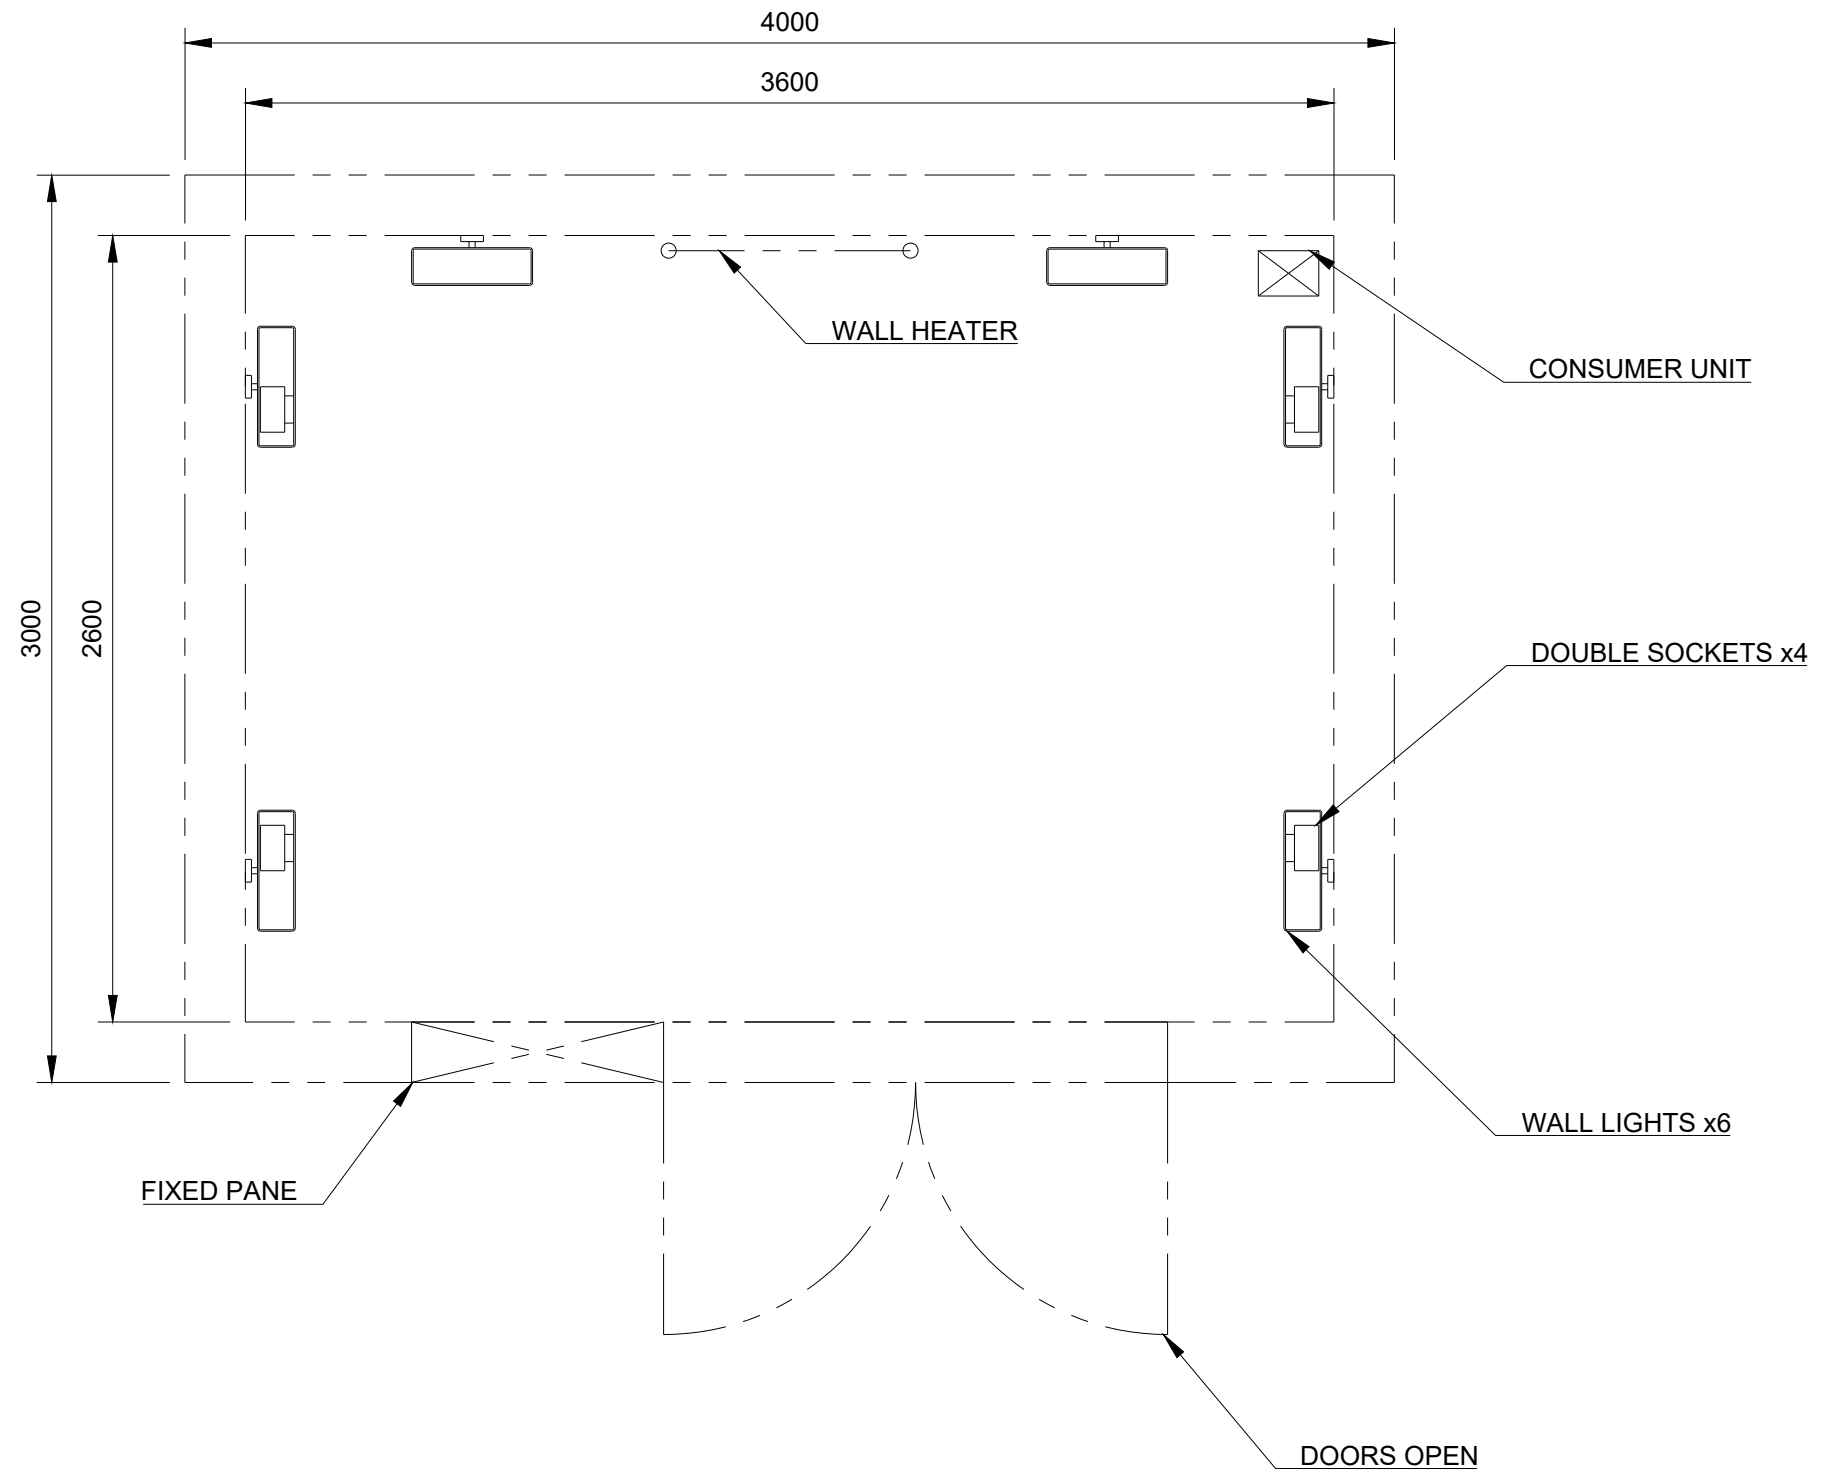

 ELECTRICAL LAYOUT / PLAN VIEW
 DOUBLE DOORS FIXED PANE ON RIGHT

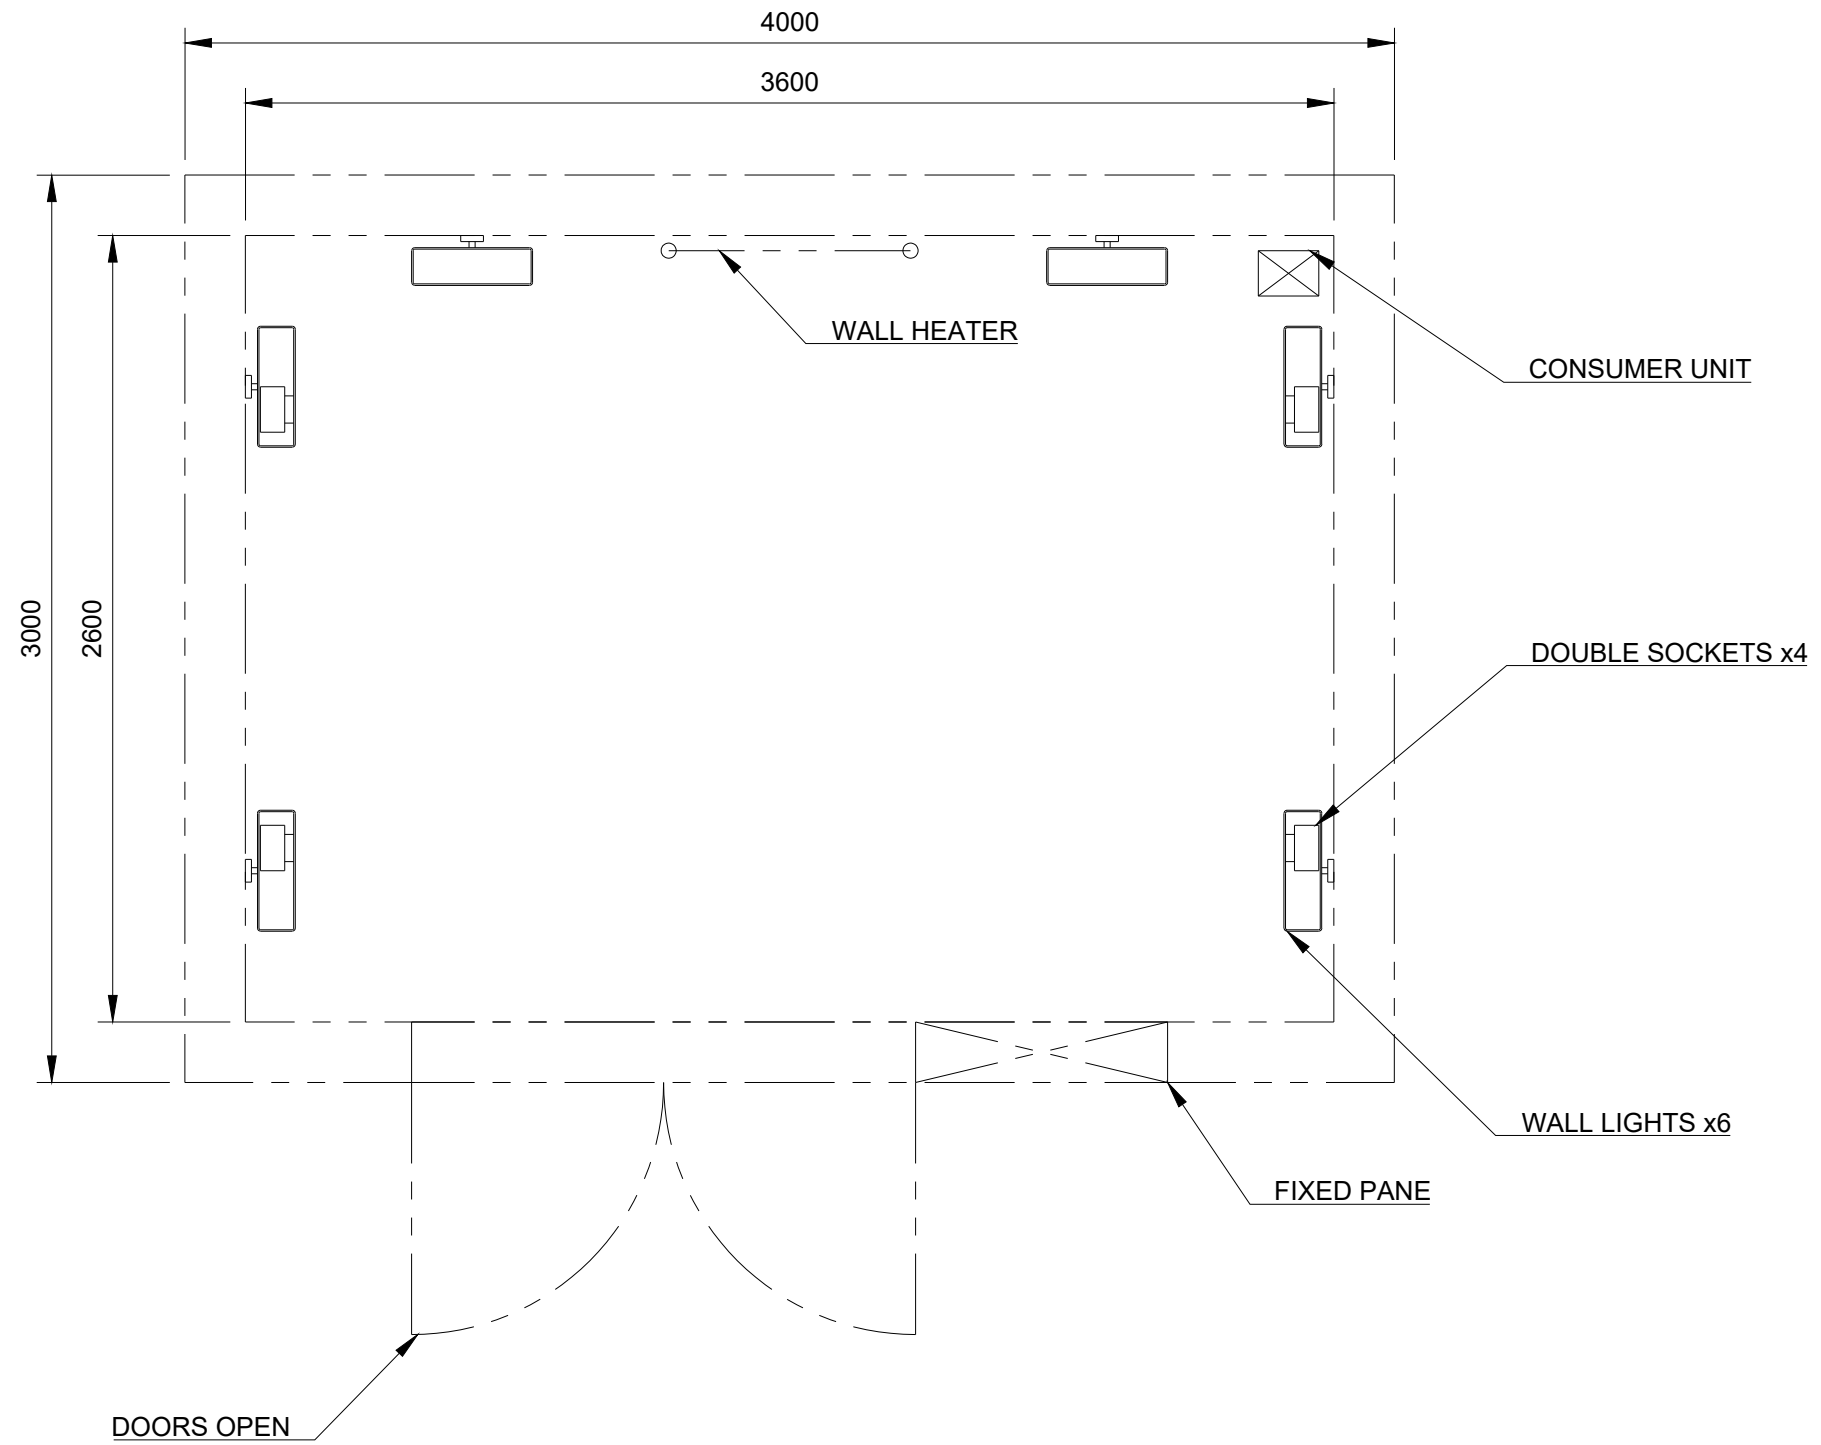

ALL DIMENSIONS IN mm.

Size

Scale

1:25

Date drawn

Created by

Approved by

Title

Tiger Modular



DWG No.

MIDI-GA-001

Rev.

Sheet

**ELECTRICAL LAYOUT / PLAN VIEW
BIFOLD LEFT TO RIGHT OPENING**

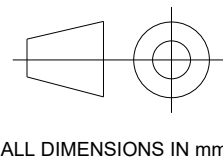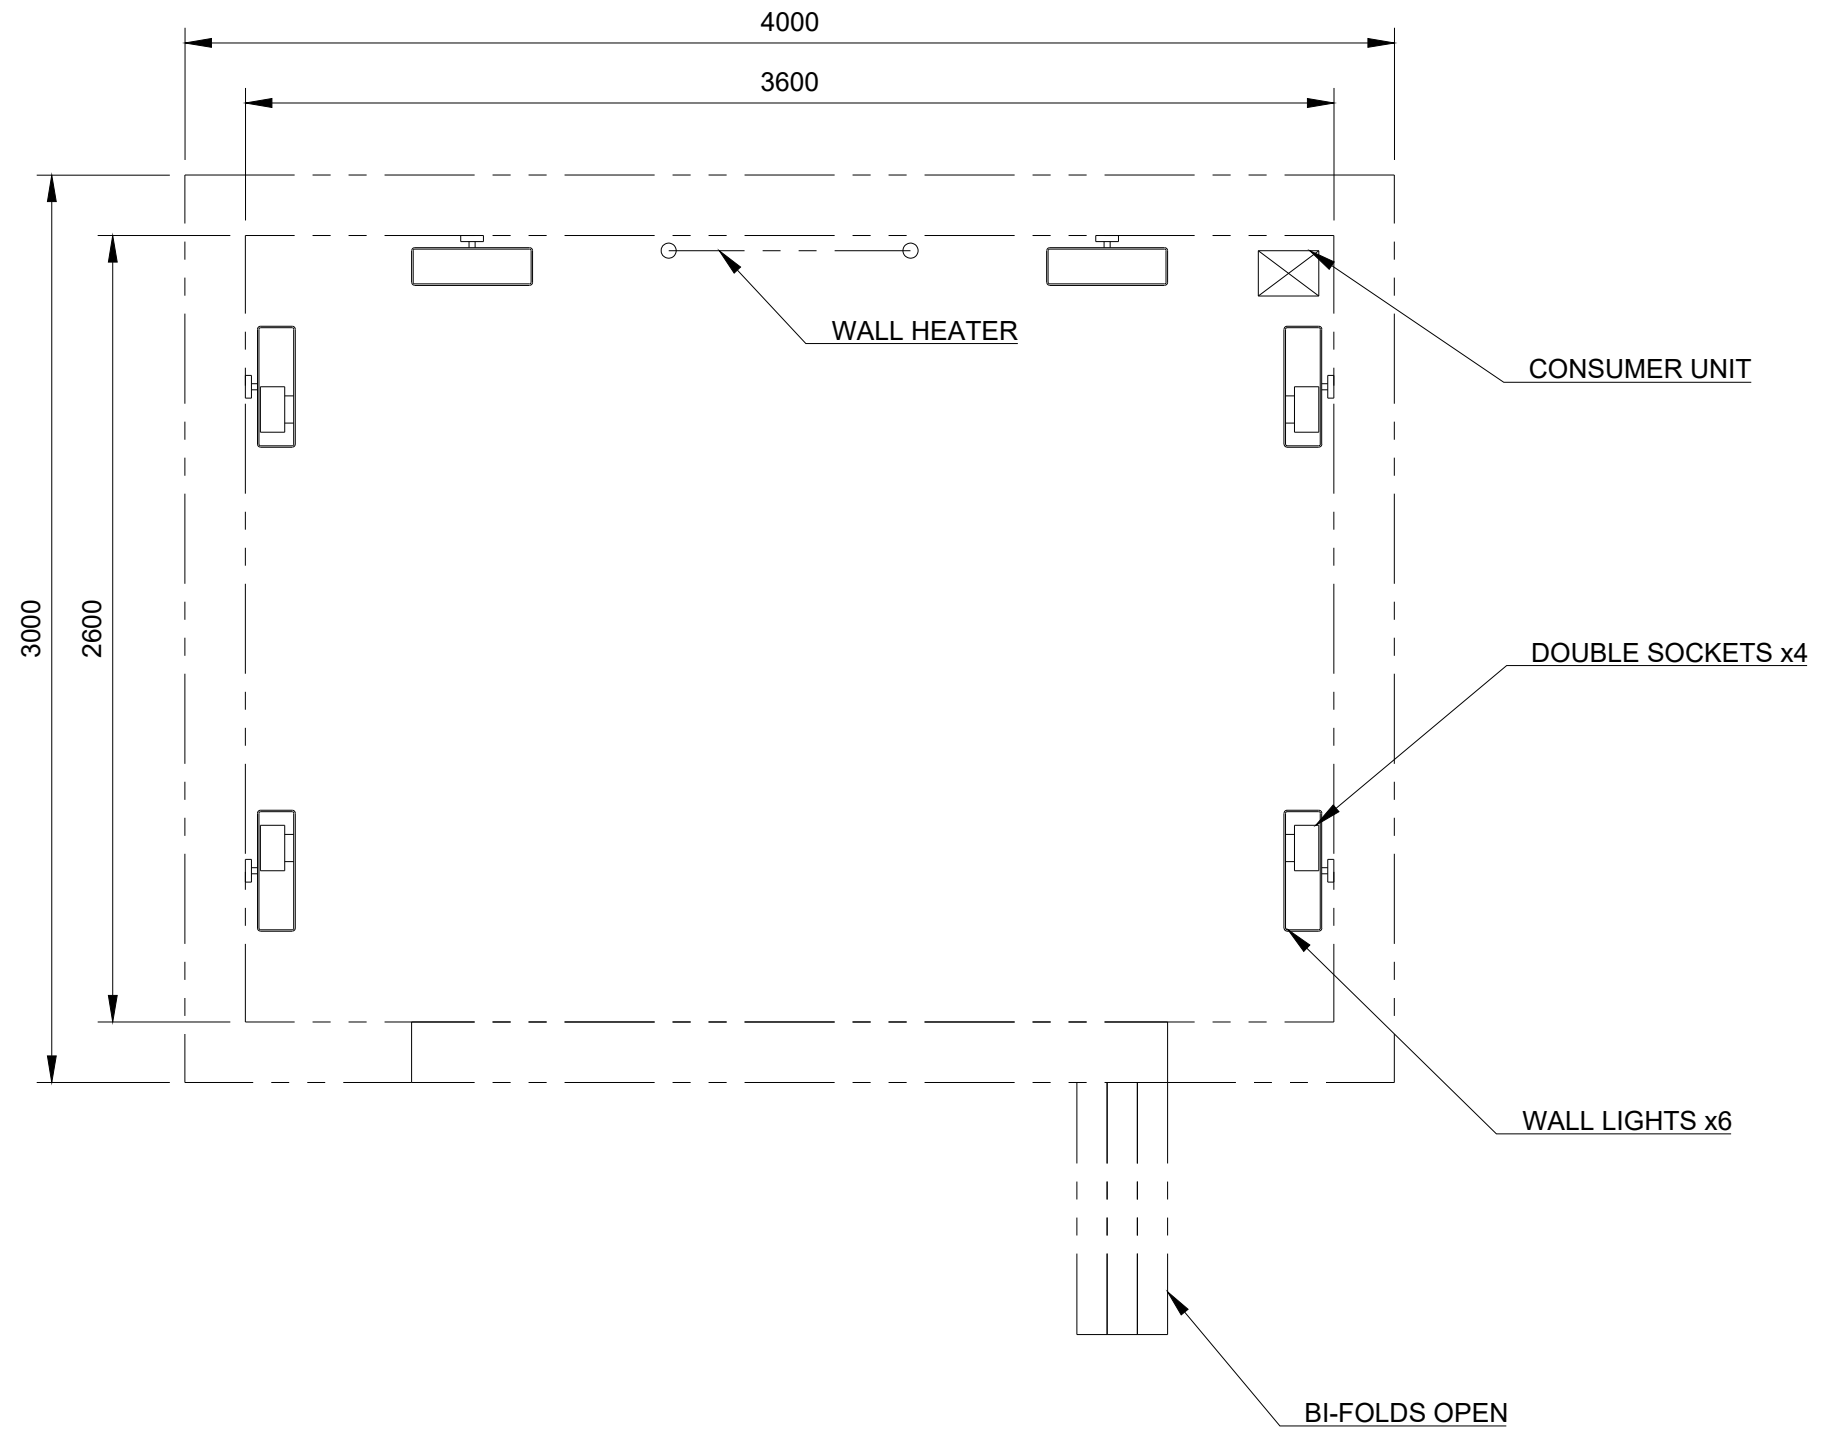

Size

Scale

1:25

Date drawn

Created by

Approved by

Title

Tiger Modular



DWG No.

MIDI-GA-001

Rev.

Sheet

**ELECTRICAL LAYOUT / PLAN VIEW
BIFOLD RIGHT TO LEFT OPENING**

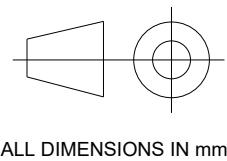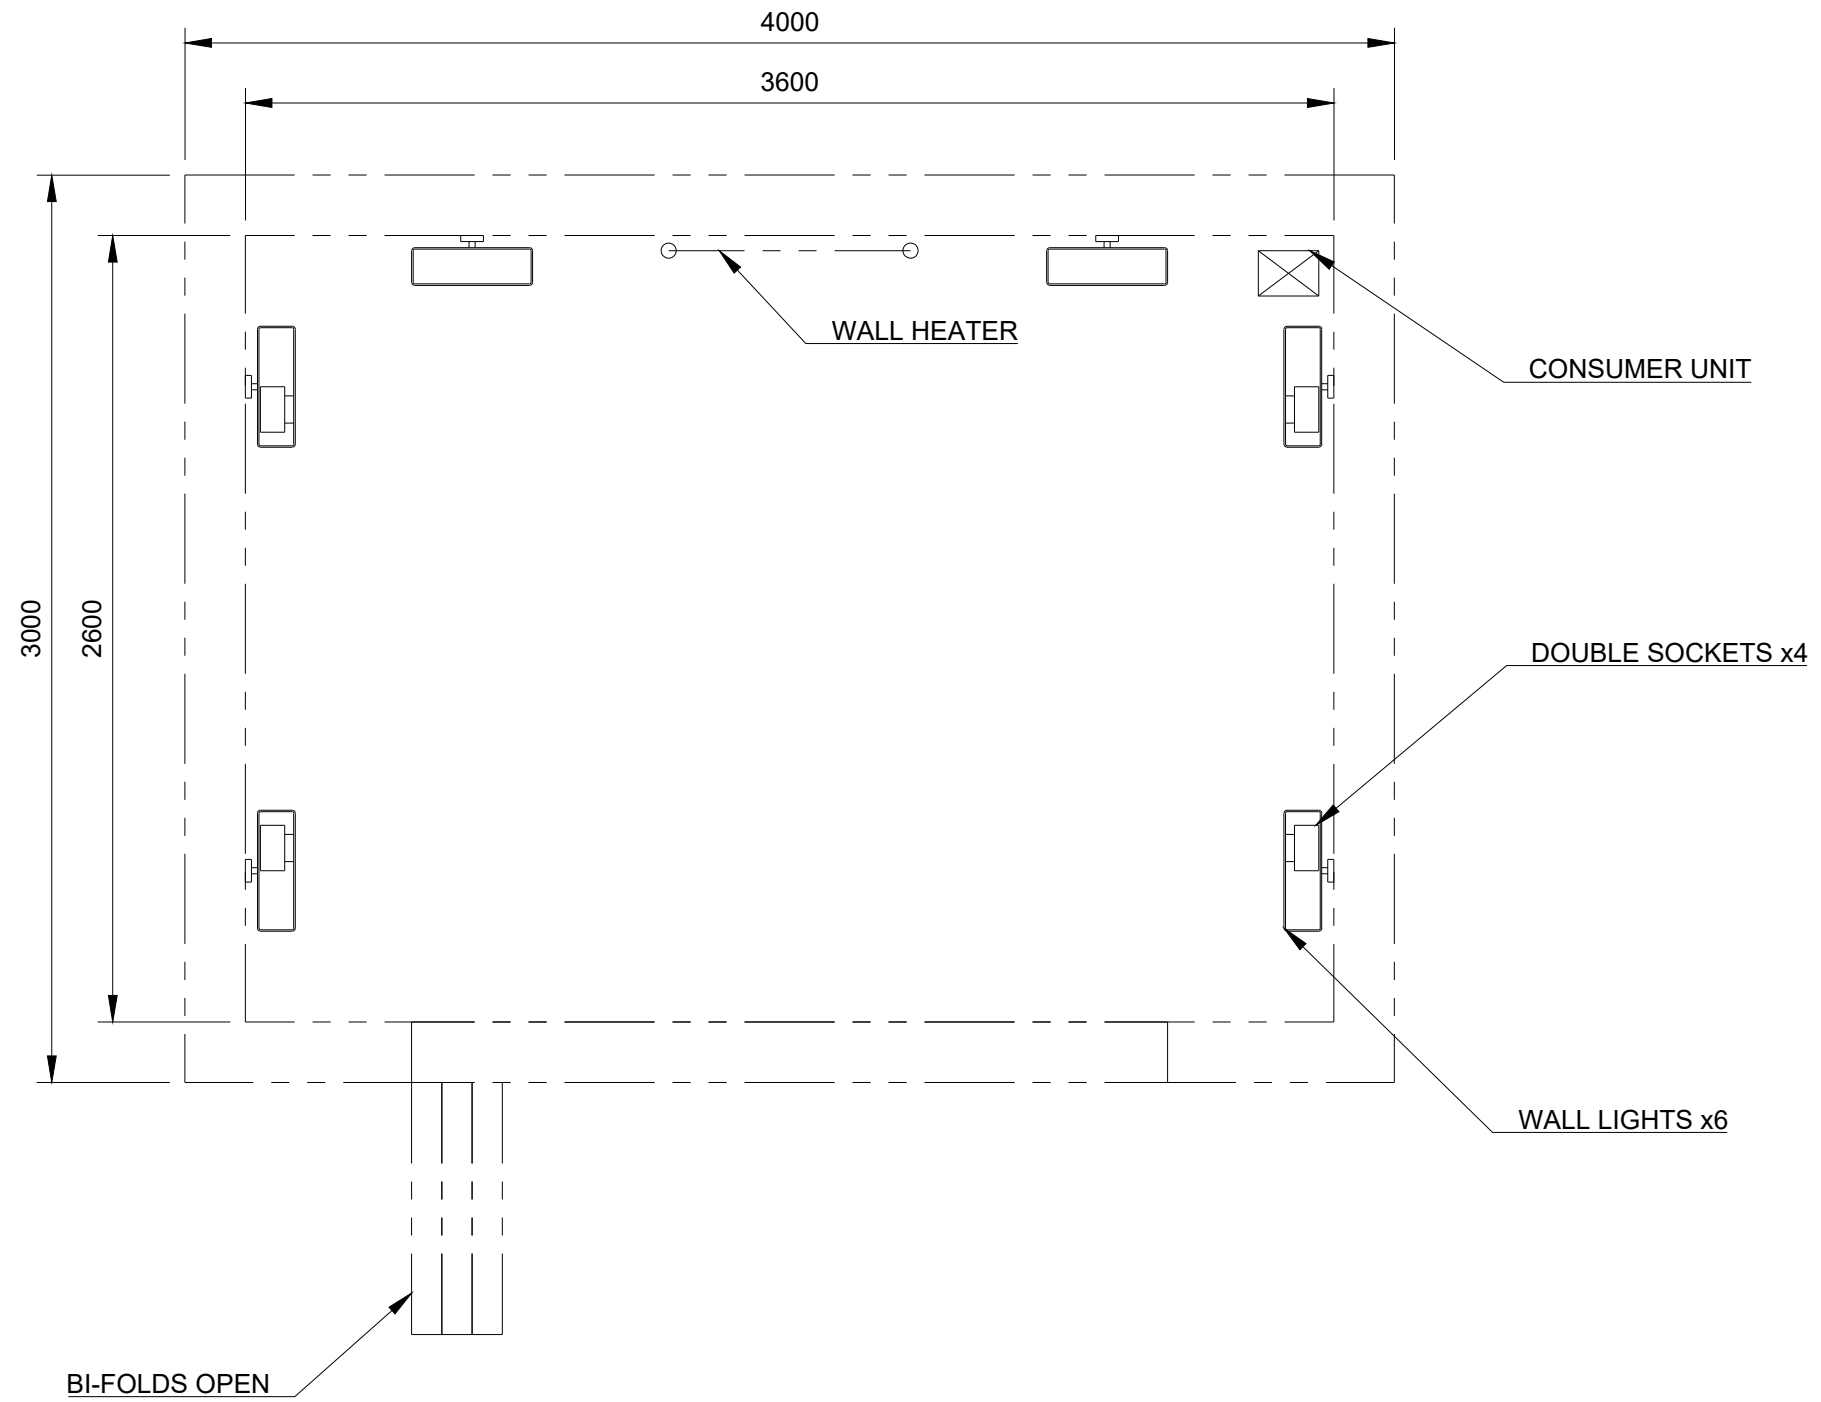

Size

Scale

1:25

Date drawn

Created by

Approved by

Title

Tiger Modular

DWG No.

MIDI-GA-001

Rev.

Sheet