

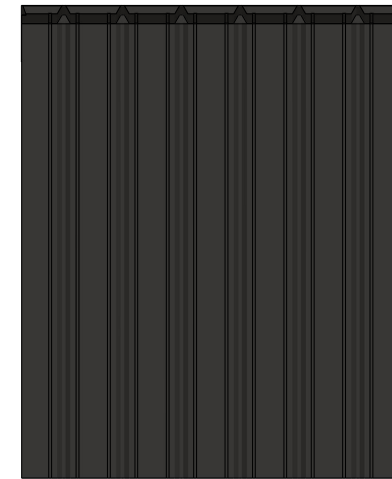


VIEW OF REAR

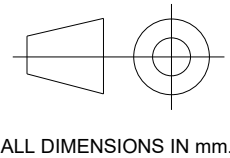

ELECTRICAL LAYOUT / PLAN VIEW

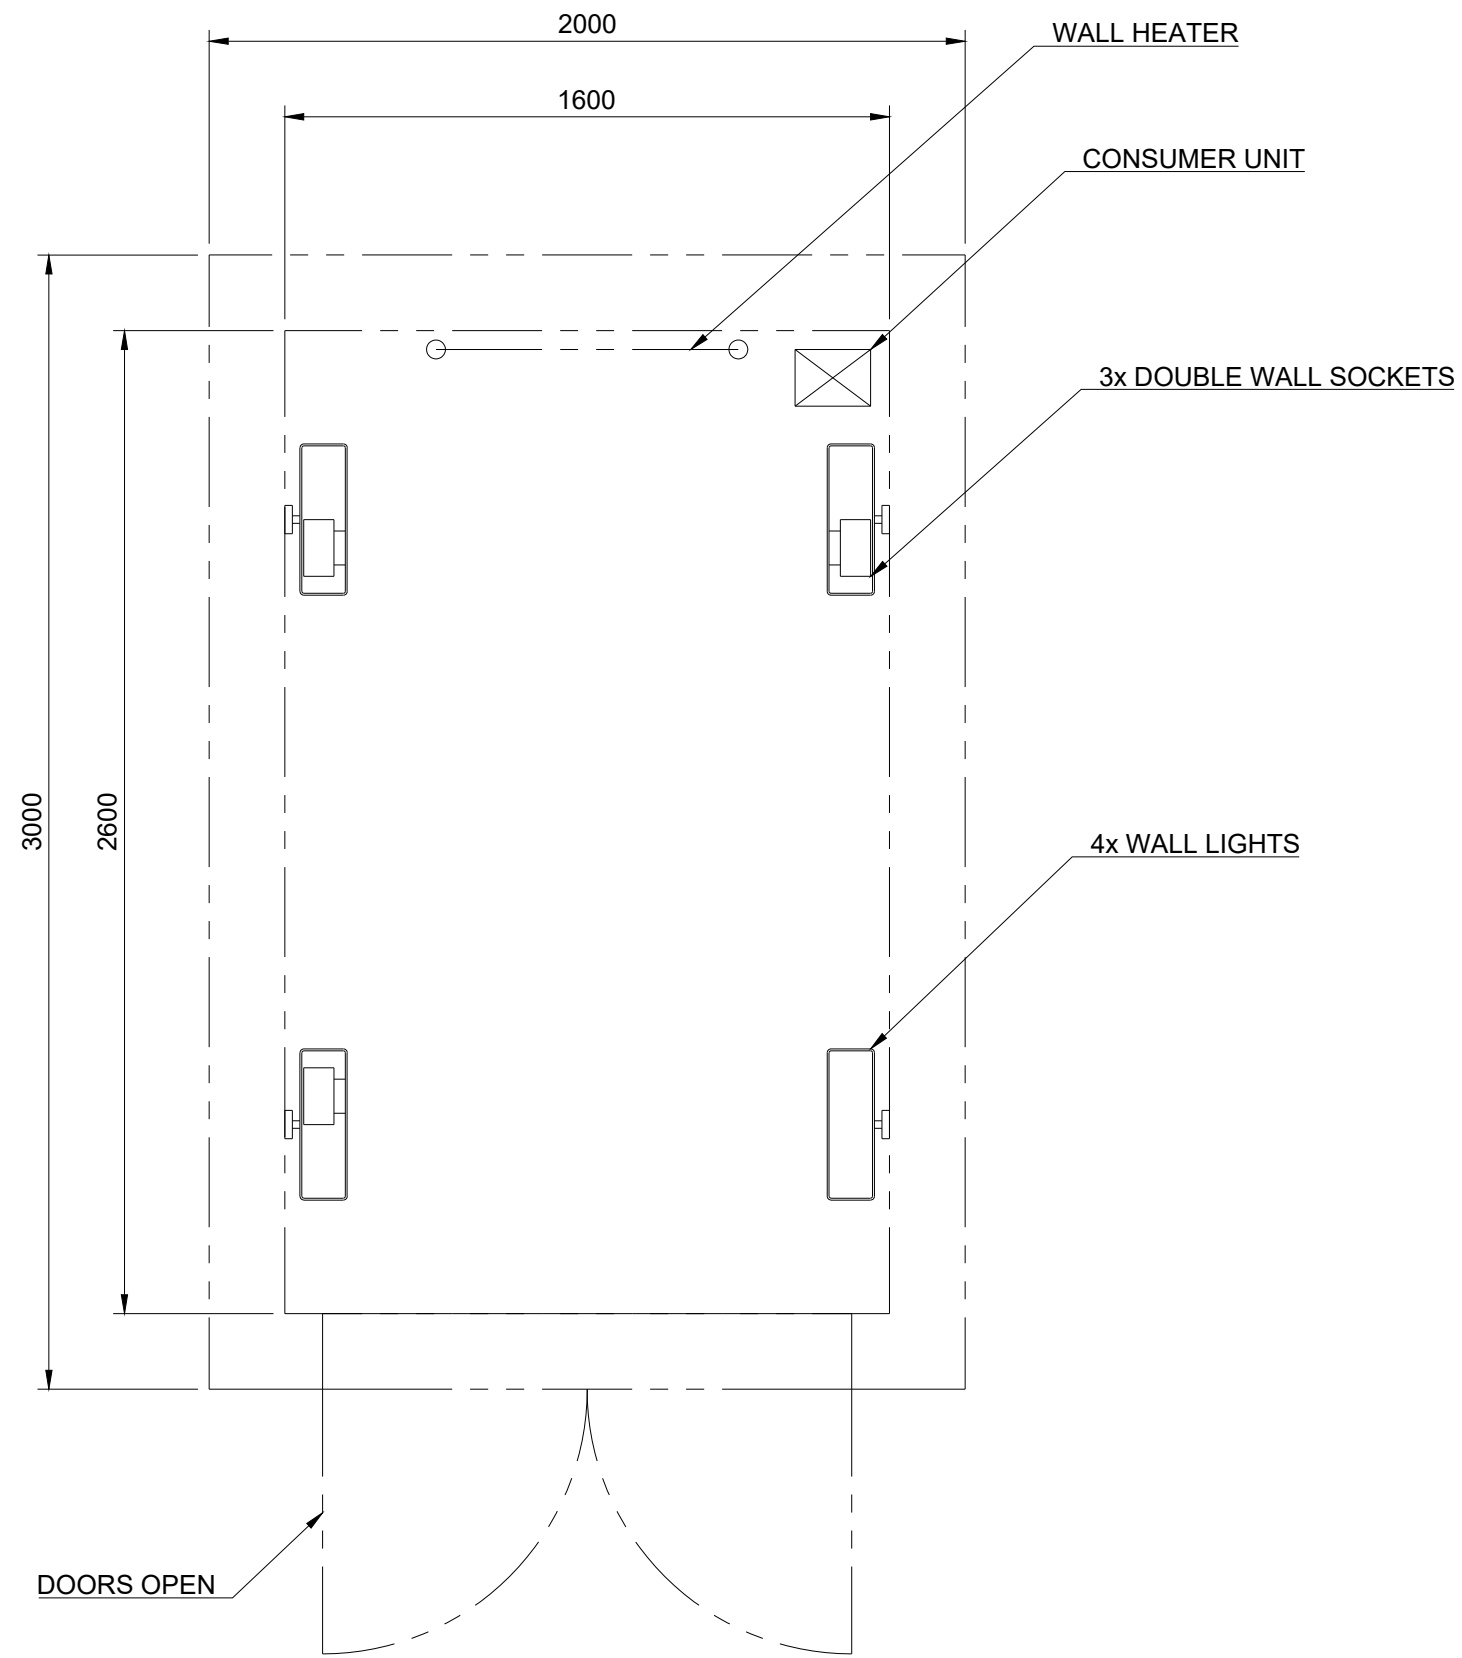

Size

Scale

1:20

Date drawn

Created by

Approved by

Title

Tiger Modular

DWG No.

MINI-GA-001

Rev.

Sheet